



**SANCTUARY LEVEL - CEILING FRAMING PLAN**  
1/4" = 1'-0"  
3rd LEVEL 8'-9"

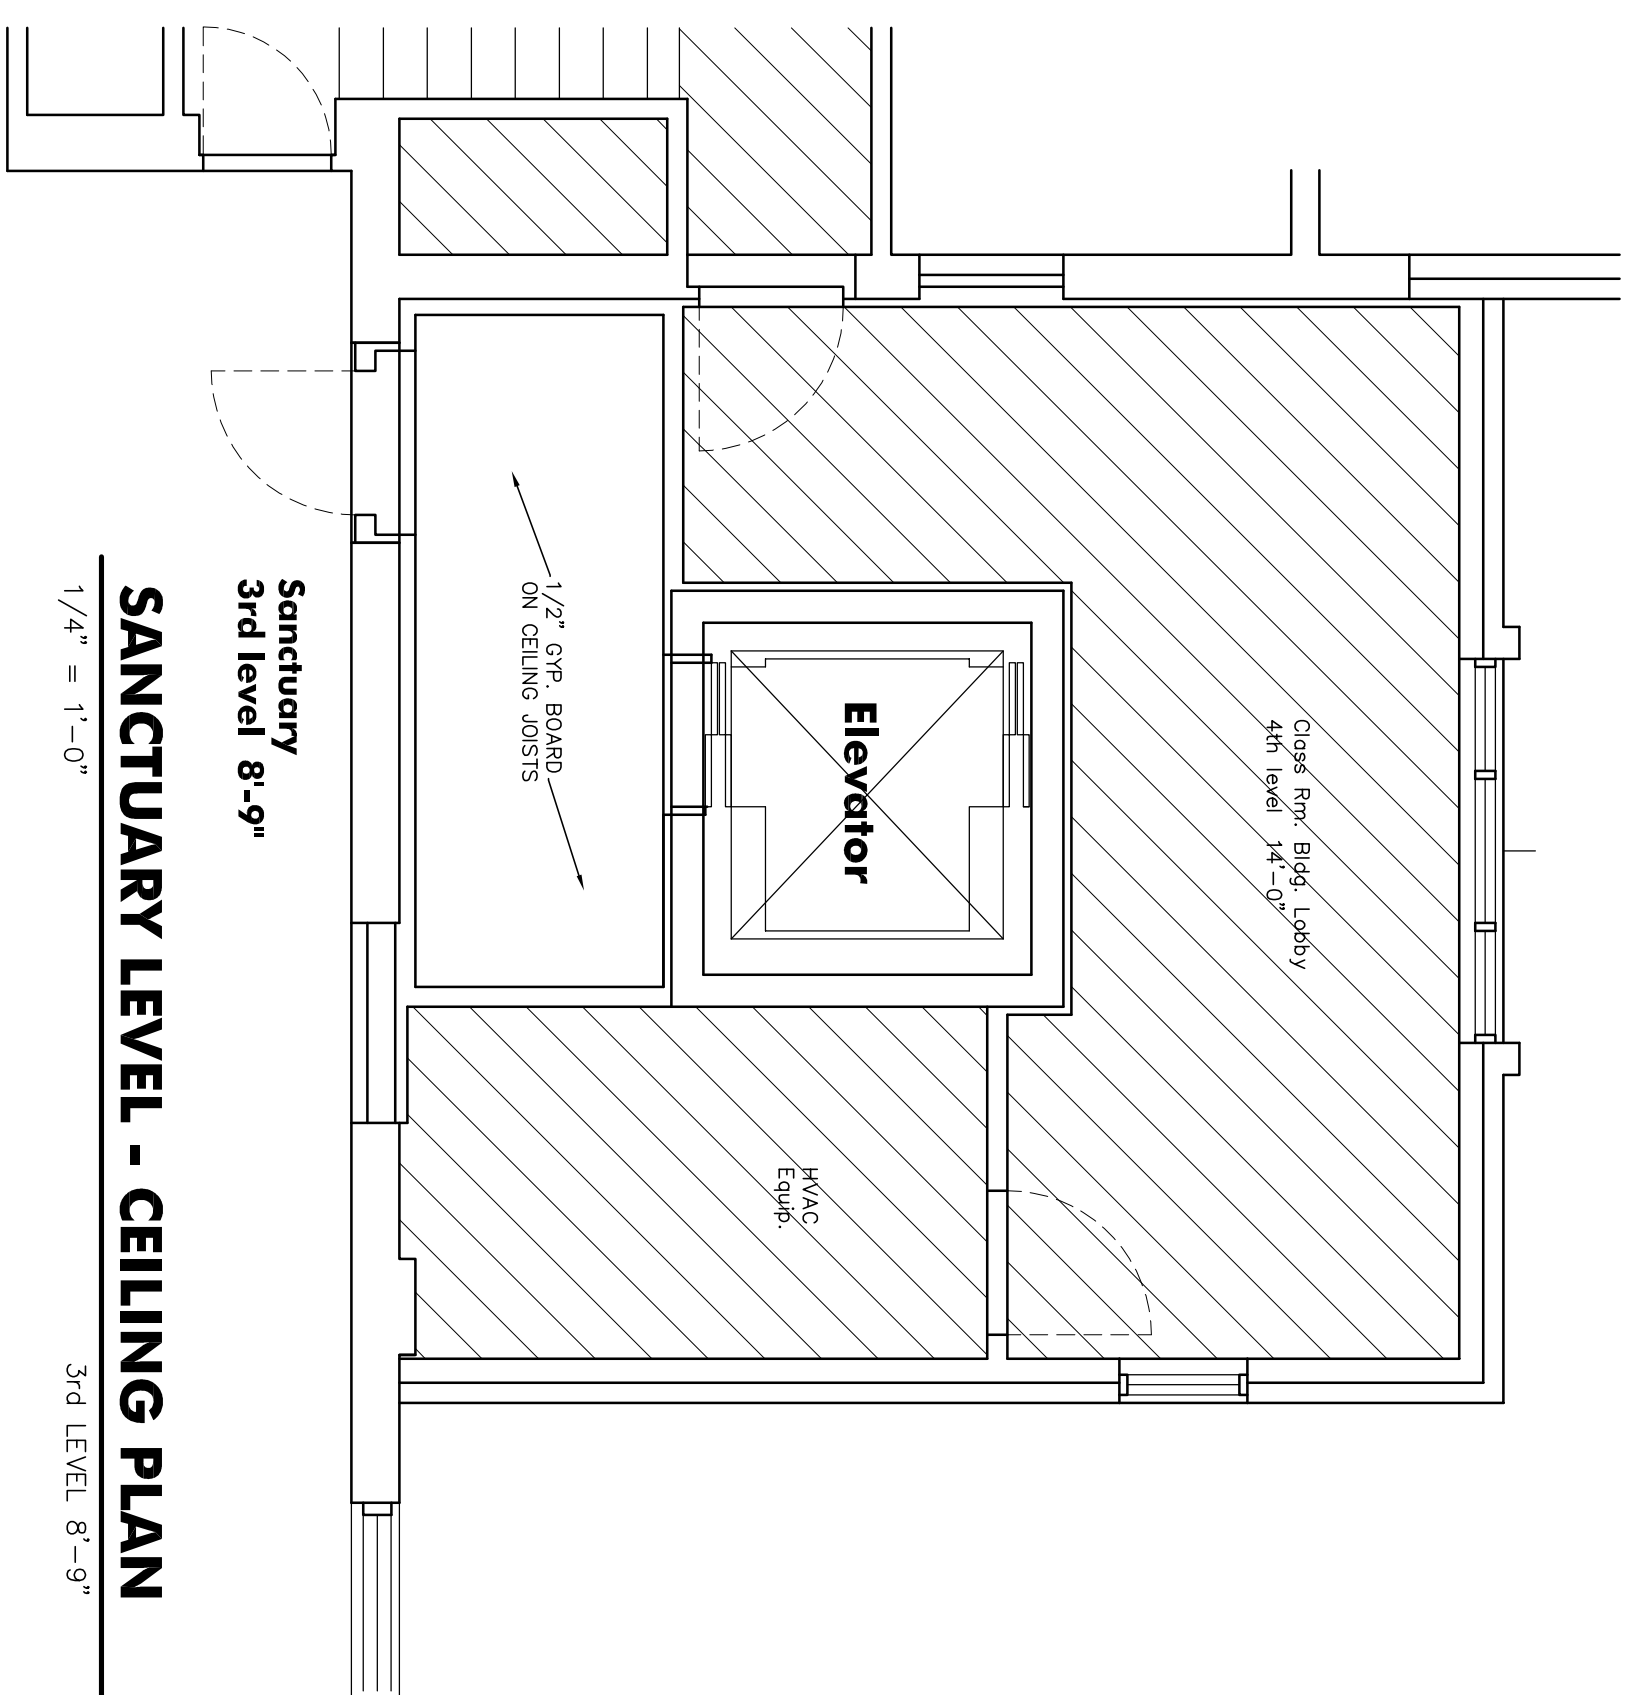

**SANCTUARY LEVEL - CEILING PLAN**  
1/4" = 1'-0"  
3rd LEVEL 8'-9"

NO.	ROOM NAME	FLOOR	BASE	WALLS	CEILING	HEIGHT	REMARKS
<b>1ST LEVEL</b>							
101	FELLOWSHIP HALL LOBBY	12X12 VCT	4" WD *	GYP-PT	GYP-PT	7'-11"	* MATCH EXISTING IN CLASS RM. BLDG.
<b>2ND LEVEL</b>							
201	C.R. BLDG. 1ST FL. LOBBY	12X12 VCT	4" WD *	GYP-PT	GYP-PT	8'-6"	* MATCH EXISTING IN CLASS RM. BLDG.
202	ELEVATOR EQUIPMENT	CONCRETE	4" WD *	GYP-PT	GYP-PT	8'-6"	* MATCH EXISTING IN CLASS RM. BLDG.
203	WOMEN	12X12 VCT	4" WD *	GYP-PT	GYP-PT	8'-6"	* MATCH EXISTING IN CLASS RM. BLDG.
204	MEN	12X12 VCT	4" WD *	GYP-PT	GYP-PT	8'-6"	* MATCH EXISTING IN CLASS RM. BLDG.
205	BATH (NURSERY)	12X12 VCT	4" WD *	GYP-PT	GYP-PT	8'-6"	* MATCH EXISTING IN CLASS RM. BLDG.
206	JANITOR	CONCRETE	4" WD *	GYP-PT	GYP-PT	8'-6"	* MATCH EXISTING IN CLASS RM. BLDG.
<b>3RD LEVEL</b>							
301	SANCTUARY LOBBY	CARPET	6" WD *	GYP-PT	GYP-PT	9'-0"	* MATCH EXISTING IN SANCT.
<b>4TH LEVEL</b>							
401	C.R. BLDG. 2ND FL. LOBBY	12X12 VCT	4" WD *	GYP-PT	GYP-PT	8'-4"	* MATCH EXISTING IN CLASS RM. BLDG.
402	HVAC EQUIPMENT	12X12 VCT	4" WD *	GYP-PT	GYP-PT	8'-4"	* MATCH EXISTING IN CLASS RM. BLDG.
403	WOMEN	12X12 VCT	4" WD *	GYP-PT	GYP-PT	8'-4"	* MATCH EXISTING IN CLASS RM. BLDG.
404	MEN	12X12 VCT	4" WD *	GYP-PT	GYP-PT	8'-4"	* MATCH EXISTING IN CLASS RM. BLDG.

ALL MATERIALS AND COLORS TO BE APPROVED BY CHURCH PRIOR TO INSTALLATION.

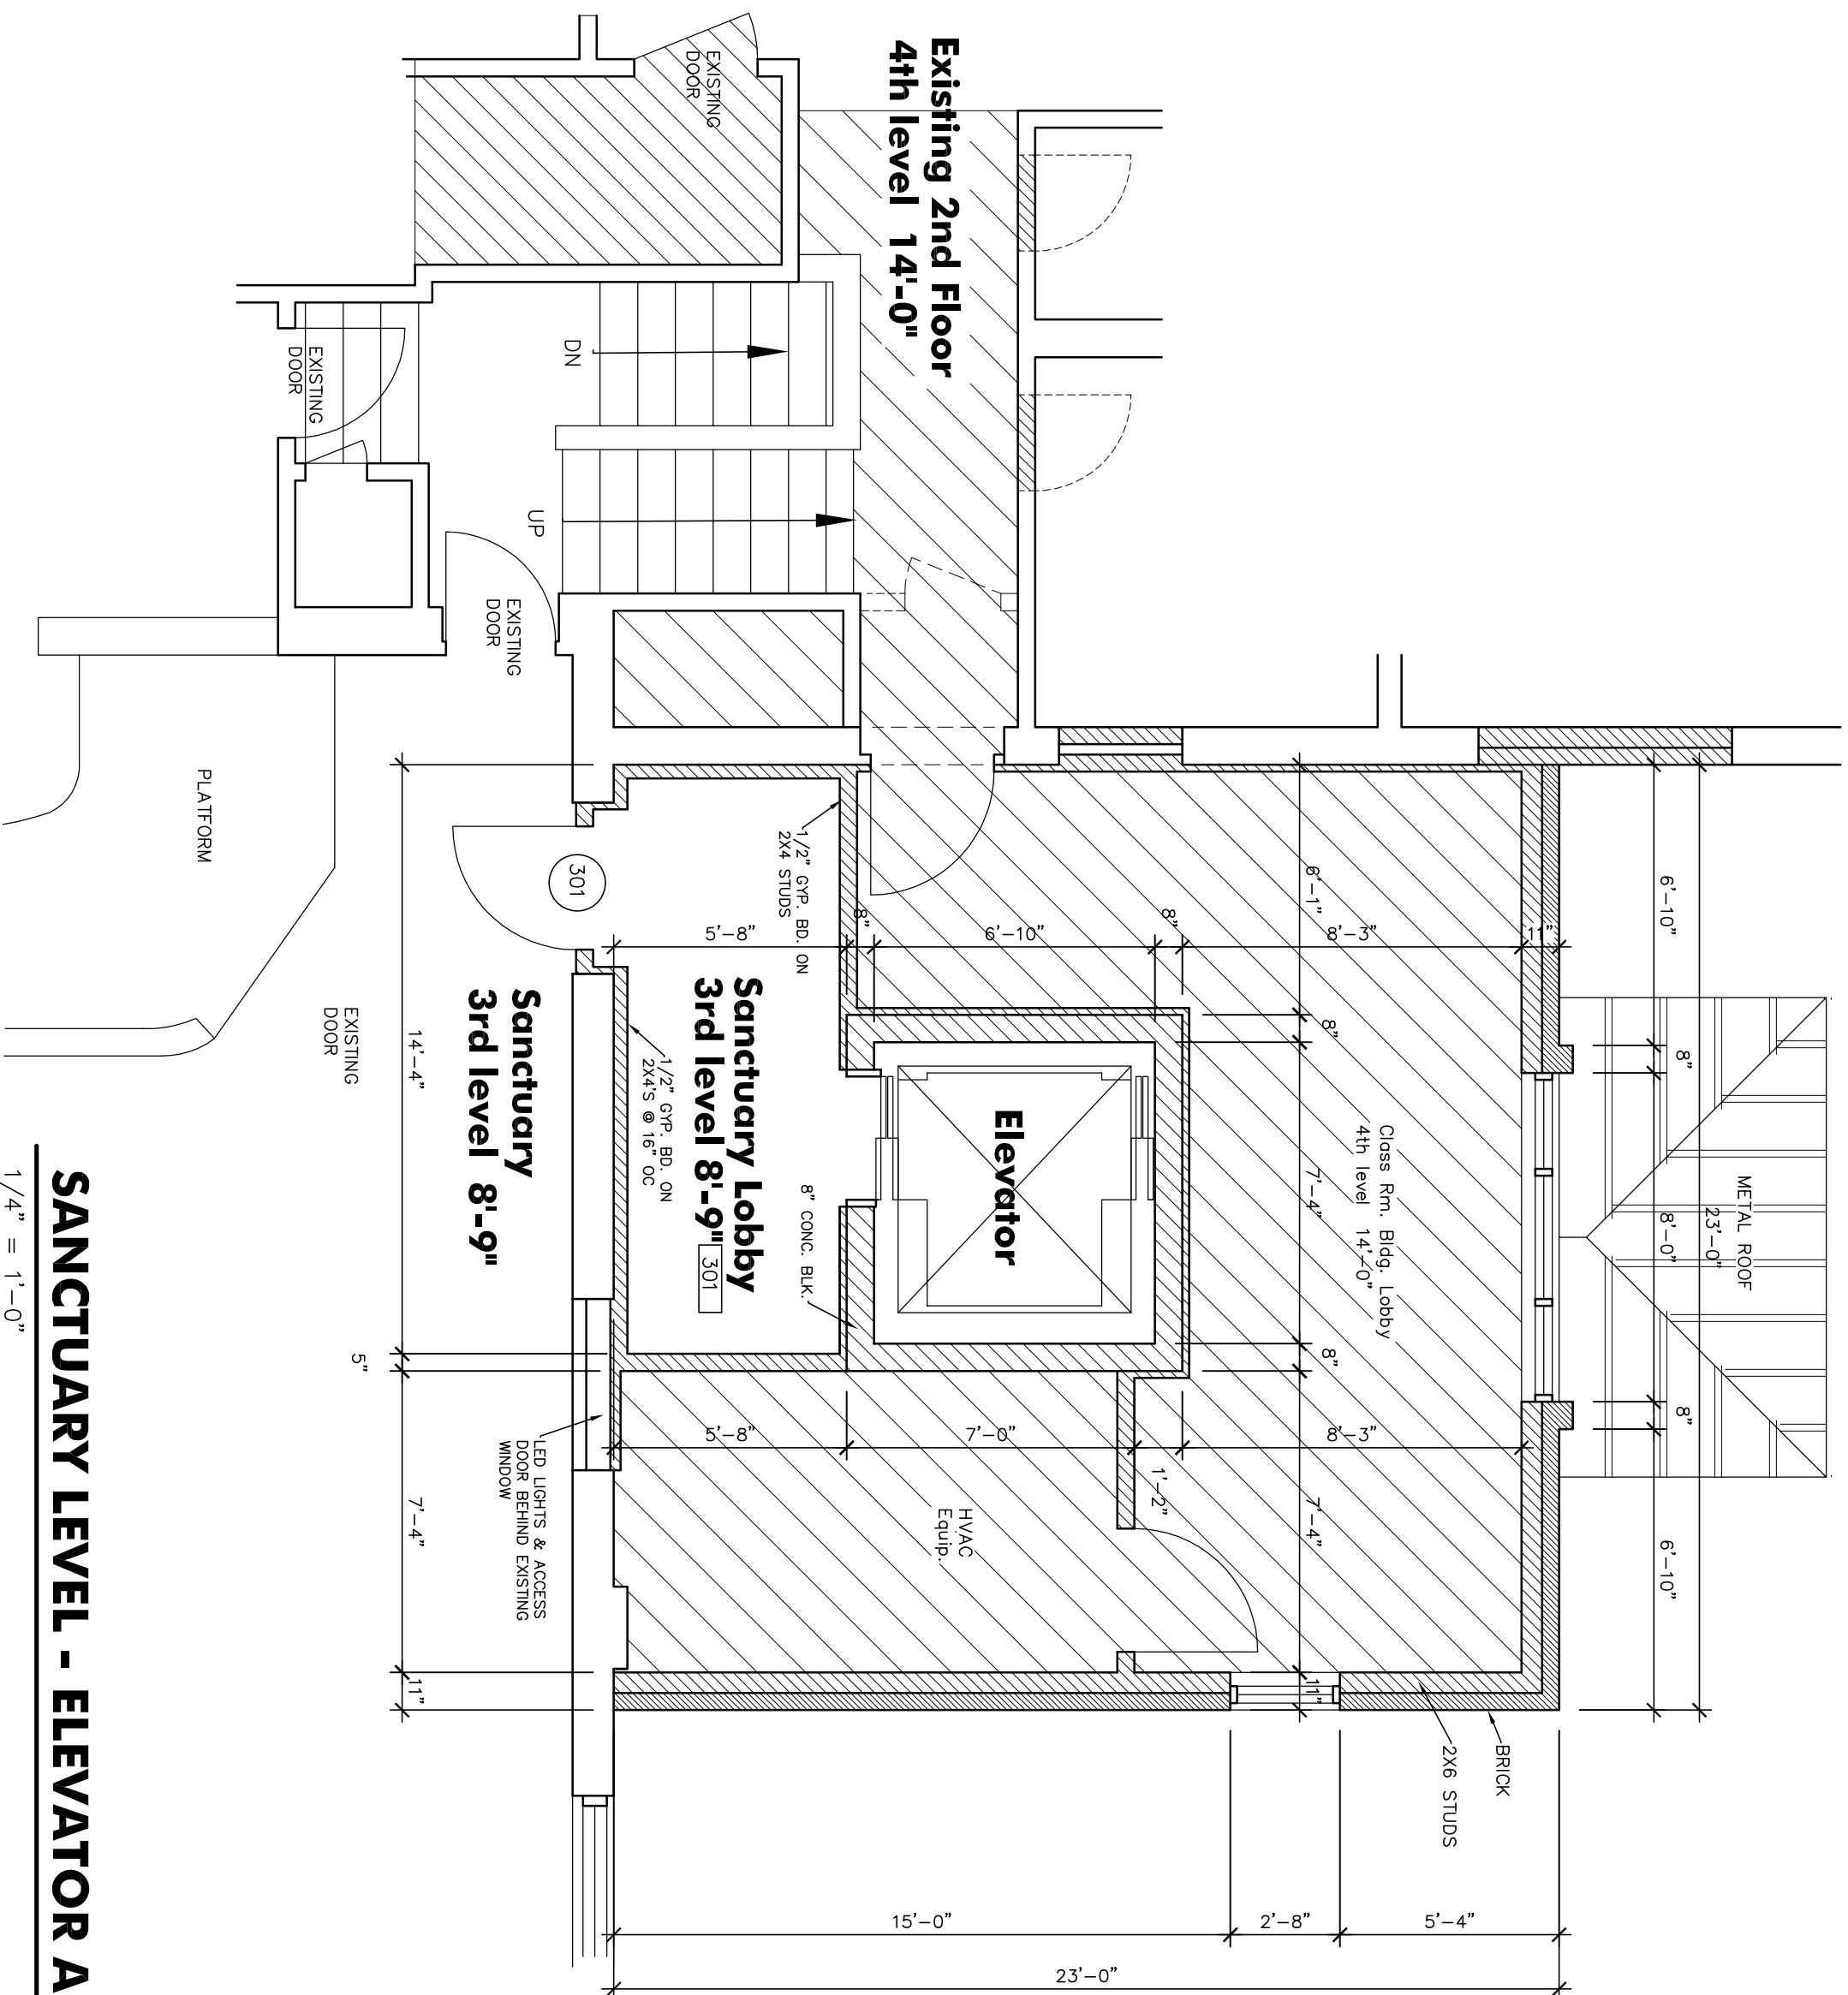

**SANCTUARY LEVEL - ELEVATOR ADDITION FLOOR PLAN**  
1/4" = 1'-0"  
3rd LEVEL 8'-9"



## Winterville United Methodist Church Elevator Addition & Bathroom Renovation

101 Parkview Road, Winterville, Georgia 30683

## Camp Architects

Camp Architects, Inc. camparch@aol.com  
P.O. Box 3386 Atlanta, Georgia 30302 404-523-2509

DRAWN: WCC  
APPROVED: WCC  
COMM. NO.: 2002  
DATE: JUNE 8, 2020  
REVISIONS:  
RELEASED FOR CONSTR.

SHEET TITLE:  
SANCTUARY LEVEL  
ELEVATOR ADDITION  
FLOOR PLAN  
SHEET NO.

**A3**

4 OF 8